



C:\Users\slking\Documents\16052 Madera CTE Modernization_2017_Current_sking.rvt

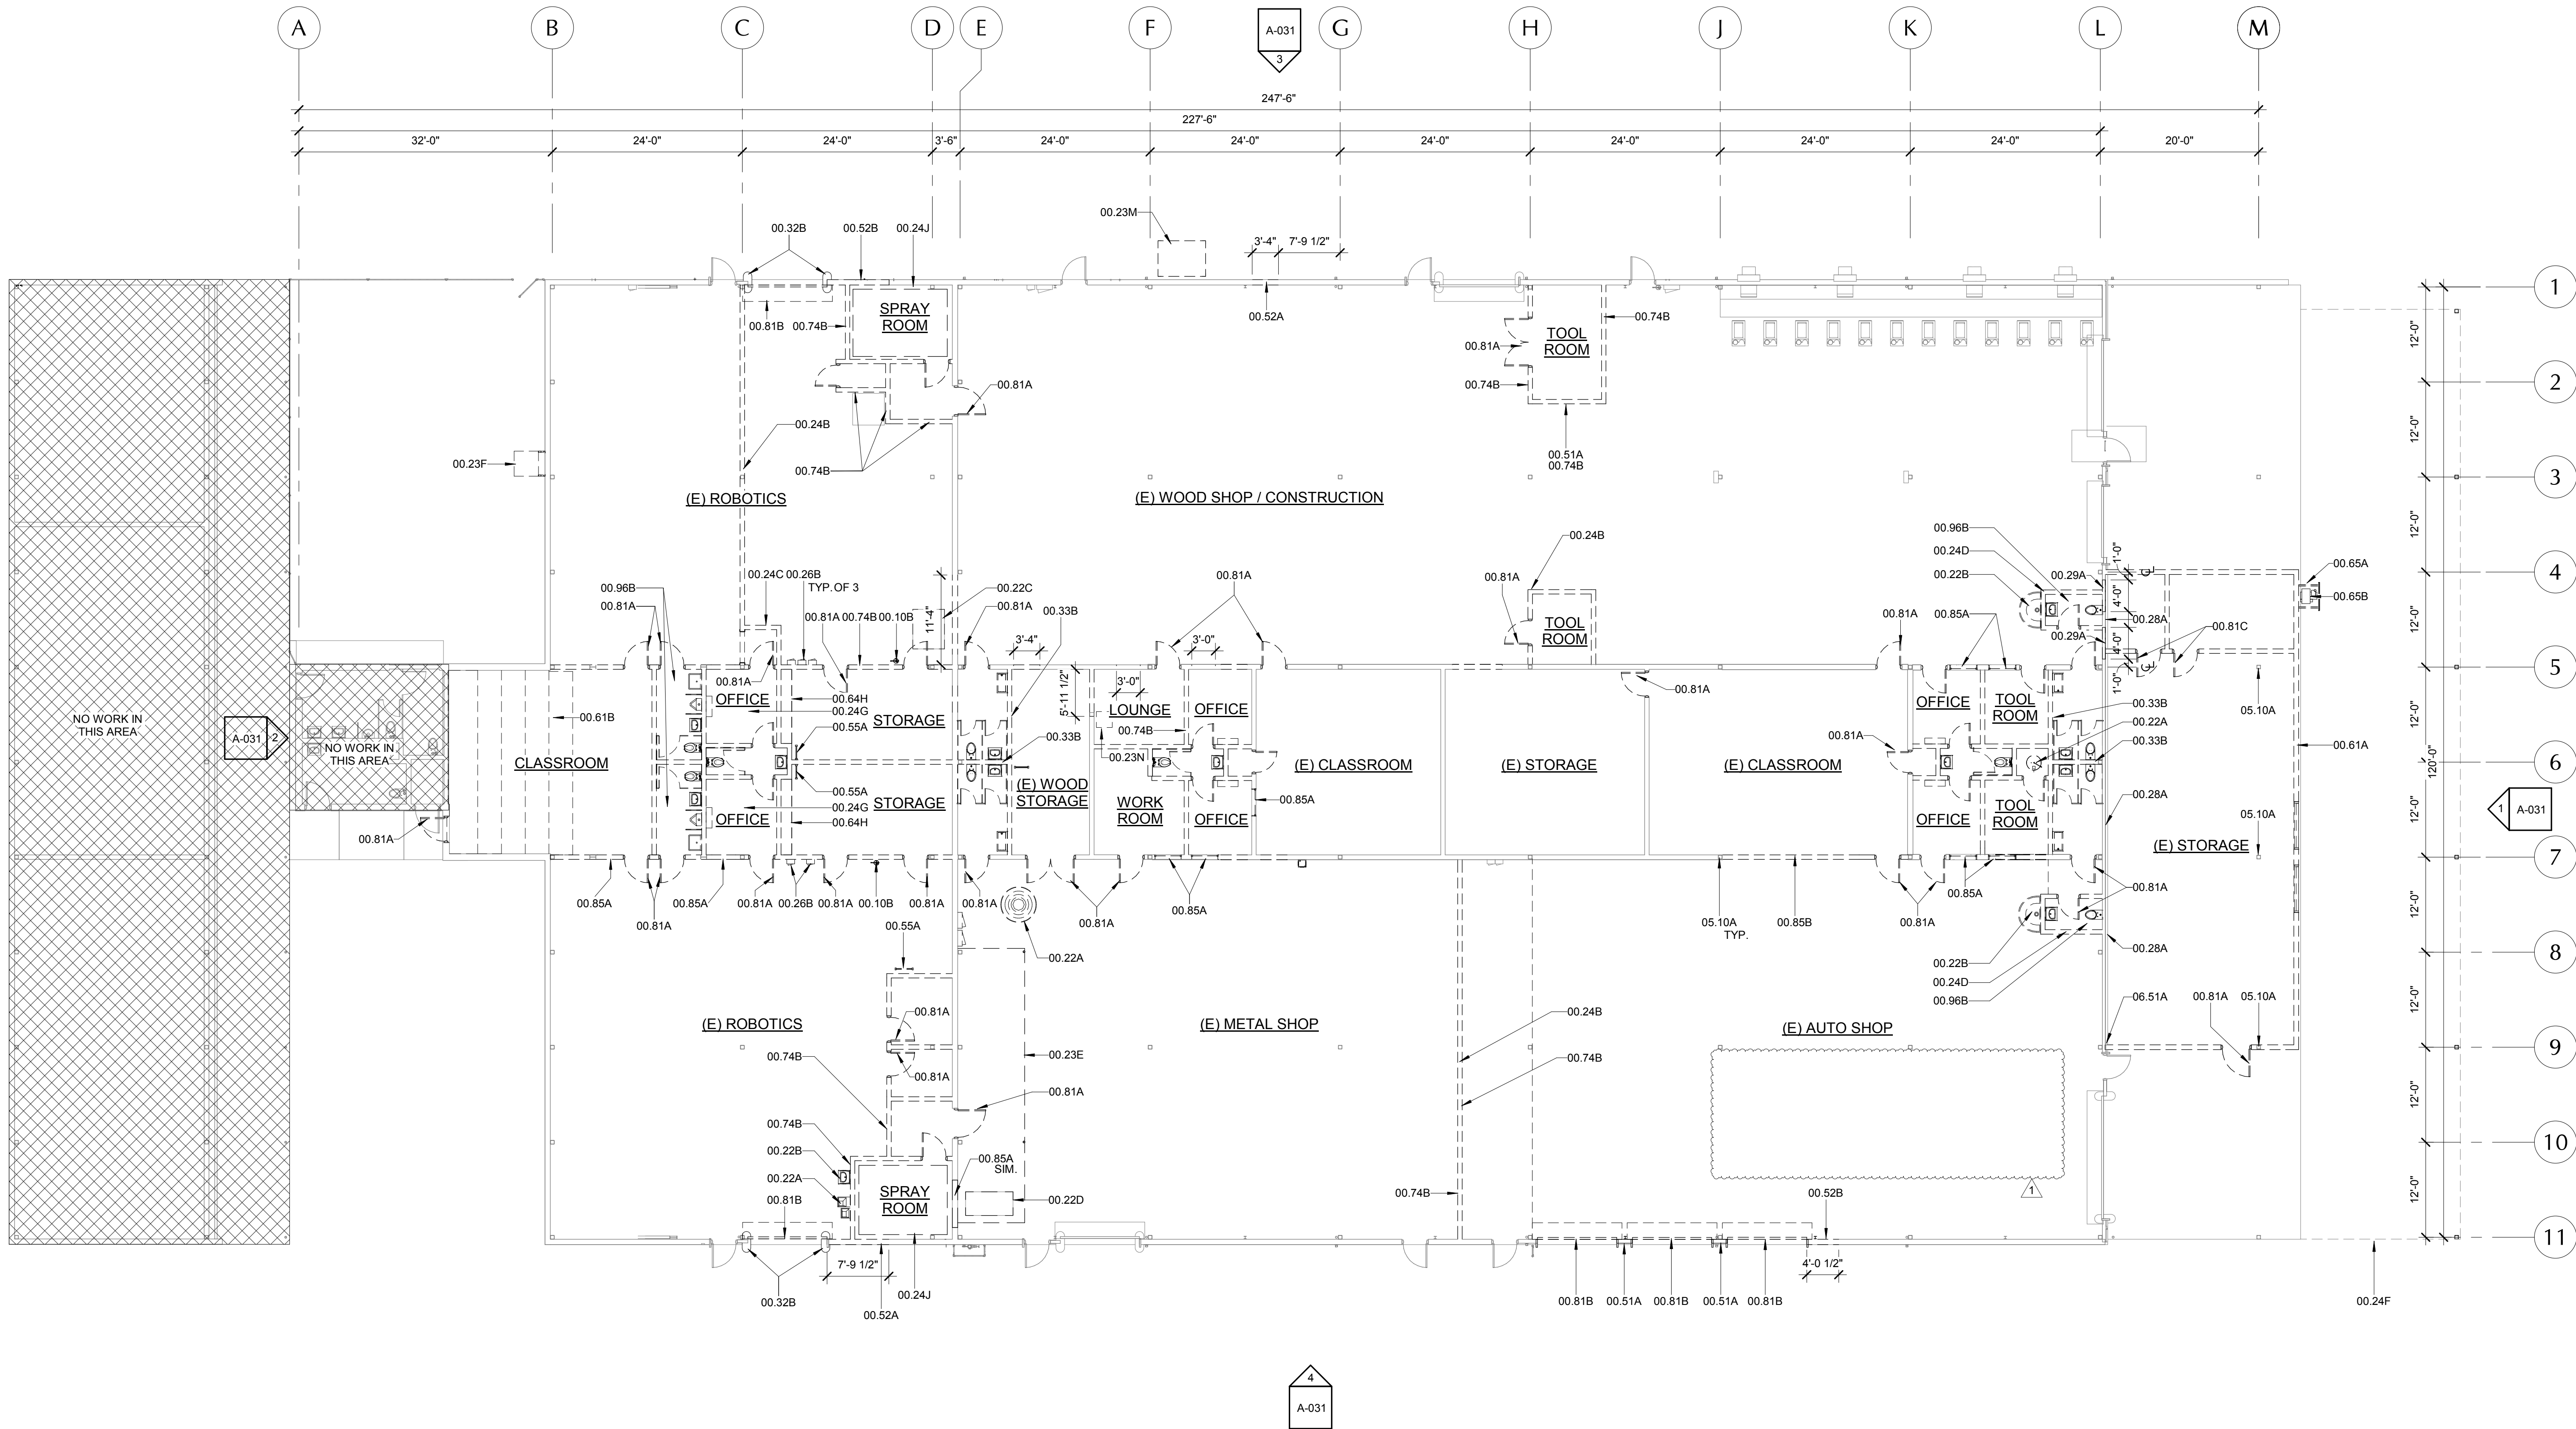

 
- DEMOLISH PLUMBING FIXTURES THROUGHOUT U.N.O. SEE PLUMBING DRAWINGS.
- ITEMS NOT NOTED TO BE DEMOLISHED OR SHOWN HEREIN ARE TO REMAIN.
- DEMO/PATCH/REPAIR CONCRETE SLAB WHERE UTILITIES ARE CALLED OUT TO BE CAPPED UNDER SLAB.

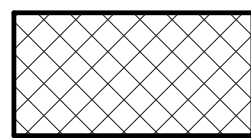

NO WORK IN THIS AREA



(E) WALL TO REMAIN



(E) WALL TO BE DEMOLISHED



(E) DOOR TO REMAIN



(E) DOOR TO BE DEMOLISHED

DEMOLITION PLAN LEGEND

00.10B	DEMOLISH (E) FIRE EXTINGUISHER CABINET	00.55A	REMOVE (E) STEEL ACCESS LADDER, SALVAGE.
00.22A	DEMOLISH (E) PLUMBING FIXTURE, SEE PLUMBING DRAWINGS	00.61A	DEMOLISH (E) WALL
00.22B	DEMOLISH (E) HAND WASH SHOP SINK	00.61B	DEMOLISH (E) RAISED, STEPPED WOOD FRAMED FLOOR PLATFORMS
00.22C	DEMOLISH (E) LARGE UTILITY VAULT BELOW AND FLUSH TO FLOOR, WITH DIAMOND PLATE DOORS	00.64H	DEMOLISH (E) SHELVING
00.22D	DEMOLISH (E) METAL FOUNDRY VAULT BELOW AND FLUSH TO FLOOR	00.65B	DEMOLISH (E) CHAIN LINK CAGE
00.23E	DEMOLISH (E) EXHAUST HOOD	00.65B	DEMOLISH (E) AIR COMPRESSOR
00.23F	DEMOLISH (E) EVAPORATIVE COOLER	00.74B	REMOVE (E) METAL SIDING, TO BE RELOCATED FOR REUSE AT ANOTHER LOCATION.
00.23M	RELOCATE (E) DUST COLLECTOR AND DUCTING PER A-201 & A-301	00.81A	DEMOLISH (E) DOOR AND FRAME
00.23N	RELOCATE (E) CABINET OF PER ELECTRICAL DRAWINGS	00.81B	DEMOLISH (E) ROLL UP DOOR
00.24B	DEMOLISH FULL HEIGHT DEMISING WALL, 12'-6" H. TO UNDERSIDE OF (E) WF BEAM	00.81C	DEMOLISH (E) DOOR
00.24C	DEMOLISH PARTIAL HEIGHT ALCOVE WALLS TO 7'-6" AFF, WITH SOFFIT AT 7'-2" OPEN ABV	00.85A	DEMOLISH (E) WINDOW UNIT
00.24D	DEMOLISH PARTIAL HEIGHT WALLS AND CEILING AND FIXTURE AT SINGLE OCC. RESTROOM	00.85B	DEMOLISH (E) HOLLOW METAL FRAMED WINDOW SYSTEM, FULL HEIGHT.
00.24F	DEMOLISH (E) ADJACENT NON-DSA EXTERIOR SHADE STRUCTURE AND SIX (6) SUPPORTING STEEL COLUMNS.	00.96B	DEMOLISH (E) TILE AND MORTAR BED
00.24G	DEMOLISH (E) MEZZANINE	05.10A	(E) STEEL COLUMN TO REMAIN. PROTECT IN PLACE.
00.24J	DEMOLISH (E) SPRAY BOOTH	06.51A	PATCH AND REPAIR (E) EXTERIOR WALLS
00.26B	DEMOLISH (E) ELECTRICAL PANEL, SEE ELECTRICAL DEMOLITION PLAN.		
00.28A	DEMOLISH (E) PLYWOOD INTERIOR FINISH		
00.29A	SELECTIVE DEMOLITION OF (E) 2X WALL FRAMING AND WALL FINISHES TO FACILITATE INSTALLATION OF (N) MECHANICAL WALL LOUVERS		
00.32B	DEMOLISH (E) CONCRETE WHEEL BUMPER		
00.33B	DEMOLISH (E) 8" H. CURB TO BELOW F.F. AT WALL TO BE DEMOLISHED		
00.51A	SELECTIVE DEMOLITION OF (E) STEEL FRAMING AND ALUMINUM SIDING TO PREPARE FOR (N) OPENING, APPROX. EXTENT SHOWN DASHED. SEE STRUCTURAL DRAWINGS		
00.52A	SELECTIVE DEMOLITION OF (E) WALL TO ALLOW FOR INSTALLATION OF (N) DOOR AT LOCATION		
00.52B	SELECTIVE DEMOLITION OF (E) WALL TO ALLOW FOR INSTALLATION OF (N) ROLL-UP AT LOCATION		

DEMOLITION FLOOR PLAN

3/32" = 1'-0"

1

PROJECT OWNER & TITLE
Madera Unified School District
1902 Howard Road
Madera, CA 93637

MADERA CTE
MODERNIZATION
200 SOUTH L STREET
MADERA, CA 93637

SHEET TITLE
DEMOLITION
FLOOR PLAN

DRAWN BY: SK, JD, SR
JOB NUMBER: 16052.01

SHEET NO.

A-021

DATE: JUNE 29, 2018

KEYNOTES

PMSM
ARCHITECTS
560 HIGUERA STREET
SUITE C
SAN LUIS OBISPO, CA 93401
TEL (805) 476-0399

CONSULTANTS

CIVIL ENGINEER
BLAIR, CHURCH & FLYNN
451 Clovis Avenue, Suite 200
Clovis, CA 93612
TEL (559) 326-1400

COST ESTIMATOR
LELAND SAYLOR ASSOCIATES
101 Montgomery Street, Suite 800
San Francisco, CA 94104
TEL (415) 291-3200


STRUCTURAL ENGINEER
BIGGS CARDOSA ASSOCIATES INC.
5250 N. Palm Avenue, Suite 211
Fresno, CA 93704
TEL (805) 499-8686

MECHANICAL ENGINEER
MECHANICAL DESIGN CONCEPTS, INC.
1060 W. Sierra, Suite 101
Fresno, CA 93711
TEL (559) 437-0376

ELECTRICAL ENGINEER
THOMAS ENGINEERING
3562 Emmon Street, Suite C
San Luis Obispo, CA 93401
TEL (805) 543-3850

FIRE PROTECTION ENGINEER
COLLINGS & ASSOCIATES, LLC
260 Maple Court, Suite 241
Ventura, CA 93003
TEL (805) 658-0003

ARCHITECT STAMP

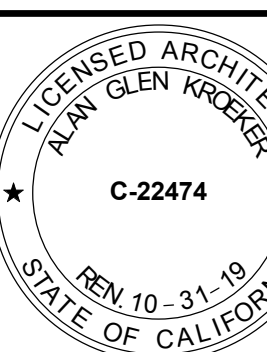

CONSULTANT STAMP

AGENCY APPROVAL

IDENTIFICATION STAMP
DIV. OF THE STATE ARCHITECT



FILE NO. 20-H3
APPL. 02-116098
AC ___ FLS ___ SS ___
DATE _____

REVISIONS

#	DATE	DESCRIPTION
1	03/28/2019	BID ADDENDUM NO. 2

THE ARCHITECT DOES NOT REPRESENT THAT THESE PLANS OR THE SPECIFICATIONS ARE SUITABLE FOR ANY SITE OTHER THAN THE ONE FOR WHICH THEY WERE SPECIFICALLY PREPARED. THE ARCHITECT DISCLAIMS RESPONSIBILITY FOR THESE PLANS AND SPECIFICATIONS IF THEY ARE USED IN WHOLE OR IN PART AT ANY OTHER SITE

C:\Users\slking\Documents\16052 Madera CTE Modernization_2017_Current_sking.rvt

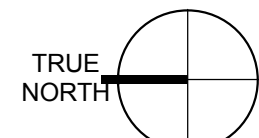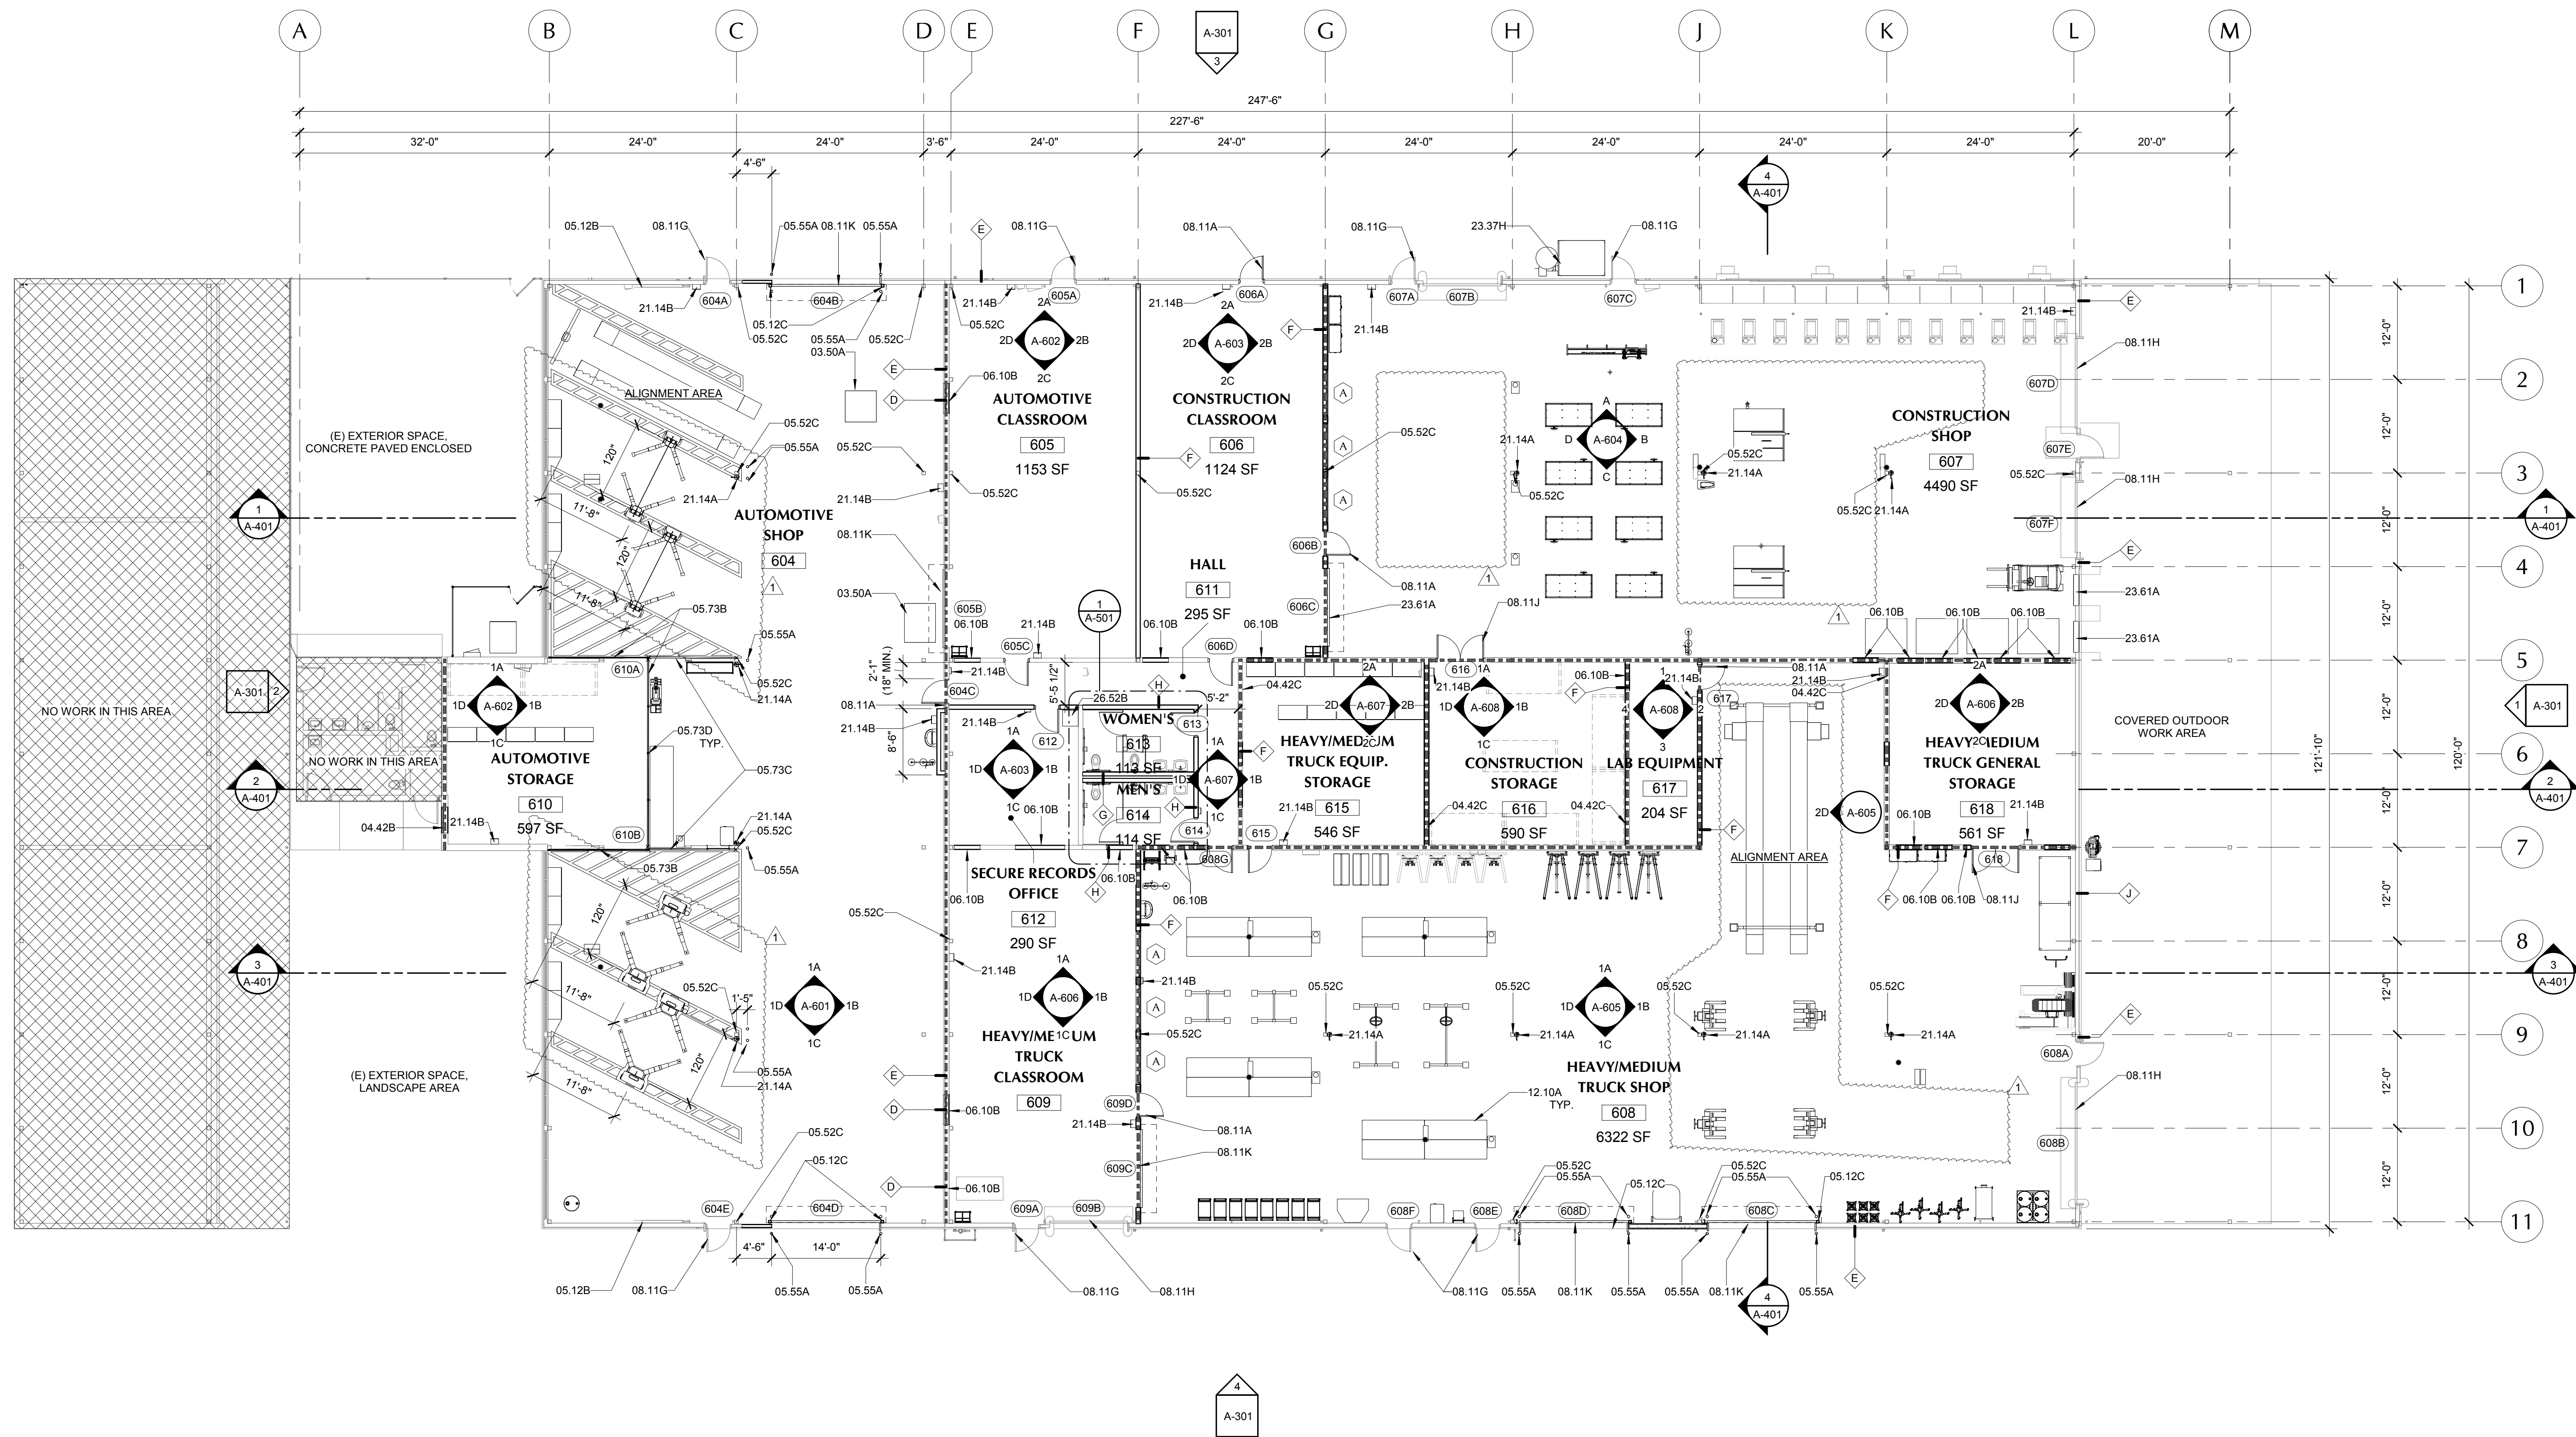

FLOOR PLAN 3/32" = 1'-0" 1A

	WINDOW TYPE, SEE A-801
	DOOR TYPE, SEE A9-801
	WALL TYPE, SEE A-901
	NO WORK IN THIS AREA

	(N) WALL
	(E) WALL
	(N) RATED 1-HR FIRE WALL, UL DES. U-314
	(E) RATED 2-HR FIRE WALL

03.50A	(N) CAST-IN-PLACE SLAB INFILL (FLUSH WITH EXISTING)
04.42B	(N) BRICK VENEER AT FRAMED WALL INFILL
04.42C	(E) WALL TO REMAIN
05.12B	(E) STRUCTURAL STEEL BRACEFRAME TO REMAIN
05.12C	(N) STRUCTURAL STEEL COLUMN PER STRUCTURAL DRAWINGS
05.52C	(E) HISS COLUMN
05.55A	(N) PROTECTIVE BOLLARD PER DETAIL, 10/A-901
05.73B	(N) FULL HEIGHT CHAIN LINK
05.73C	(N) 6 FT. H. CHAIN LINK TO (E) BRACE FRAMES
05.73D	(N) CHAIN LINK FENCE POST
06.10B	(N) WOOD STUD INFILL OF (E) WALL OPENING, MATCH (E) WALL WIDTH
08.11A	(N) HOLLOW METAL DOOR AND FRAME, PAINTED
08.11G	(E) DOOR TO REMAIN
08.11H	(E) ROLL UP DOOR TO REMAIN
08.11J	(N) DBL DOOR IN MODIFIED (E) OPENING
08.11K	(N) ROLL UP DOOR
12.10A	(N) SHOP WORK BENCH-FIXED, TYP.
21.14A	FIRE EXTINGUISHER
21.14B	FIRE EXTINGUISHER CABINET WITH FIRE EXTINGUISHER
23.37H	RELOCATED (E) DUST COLLECTOR
23.61A	(N) BACKDRAFT DAMPER PER MECHANICAL SHEET M-201, IN (N) OPENING PER 2/S-400 IN (E) 2X WALL FRAMING
26.52B	RELOCATED (E) IDF CABINET PER ELECTRICAL DRAWINGS

PROJECT OWNER & TITLE
Madera Unified School District
1902 Howard Road
Madera, CA 93637

MADERA CTE
MODERNIZATION
200 SOUTH L STREET
MADERA, CA 93637

SHEET TITLE
BUILDING FLOOR
PLAN

DRAWN BY: SK, JD, SR JOB NUMBER: 16052.01
SHEET NO.

A-201

DATE: JUNE 29, 2018

PMSM
ARCHITECTS
560 HIGUERA STREET
SUITE C
SAN LUIS OBISPO, CA 93401
TEL (805) 476-0399

CONSULTANTS

CIVIL ENGINEER
BLAIR, CHURCH & FLYNN
451 Clovis Avenue, Suite 200
Clovis, CA 93612
TEL (559) 326-1400

COST ESTIMATOR
LELAND SAYLOR ASSOCIATES
101 Montgomery Street, Suite 800
San Francisco, CA 94104
TEL (415) 291-3200


STRUCTURAL ENGINEER
BIGGS CARDOSA ASSOCIATES INC.
5250 N. Palm Avenue, Suite 211
Fresno, CA 93704
TEL (805) 499-8686

MECHANICAL ENGINEER
MECHANICAL DESIGN CONCEPTS, INC.
1060 W. Sierra, Suite 101
Fresno, CA 93711
TEL (559) 437-0376

ELECTRICAL ENGINEER
THOMA ENGINEERING
3562 Emory Street, Suite C
San Luis Obispo, CA 93401
TEL (805) 543-3850

FIRE PROTECTION ENGINEER
COLLINGS & ASSOCIATES, LLC
260 Maple Court, Suite 241
Ventura, CA 93003
TEL (805) 658-0003

ARCHITECT STAMP CONSULTANT STAMP

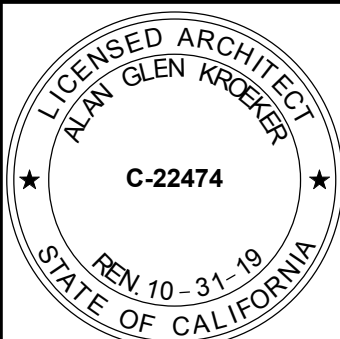

AGENCY APPROVAL
IDENTIFICATION STAMP
DIV. OF THE STATE ARCHITECT


FILE NO. 20-H3
APPL. 02-116098
AC ___ FL ___ SS ___
DATE _____

REVISIONS


NO.	DATE	DESCRIPTION
1	03/28/2019	BID ADDENDUM NO. 2

THE ARCHITECT DOES NOT REPRESENT THAT
THESE PLANS OR THE SPECIFICATIONS ARE
SUITABLE FOR ANY SITE OTHER THAN THE ONE
FOR WHICH THEY WERE SPECIFICALLY
PREPARED. THE ARCHITECT DISCLAIMS
RESPONSIBILITY FOR THESE PLANS AND
SPECIFICATIONS IF THEY ARE USED IN WHOLE OR
IN PART AT ANY OTHER SITE

C:\Users\slking\Documents\16052 Madera CTE Modernization_2017_Current_sking.rvt

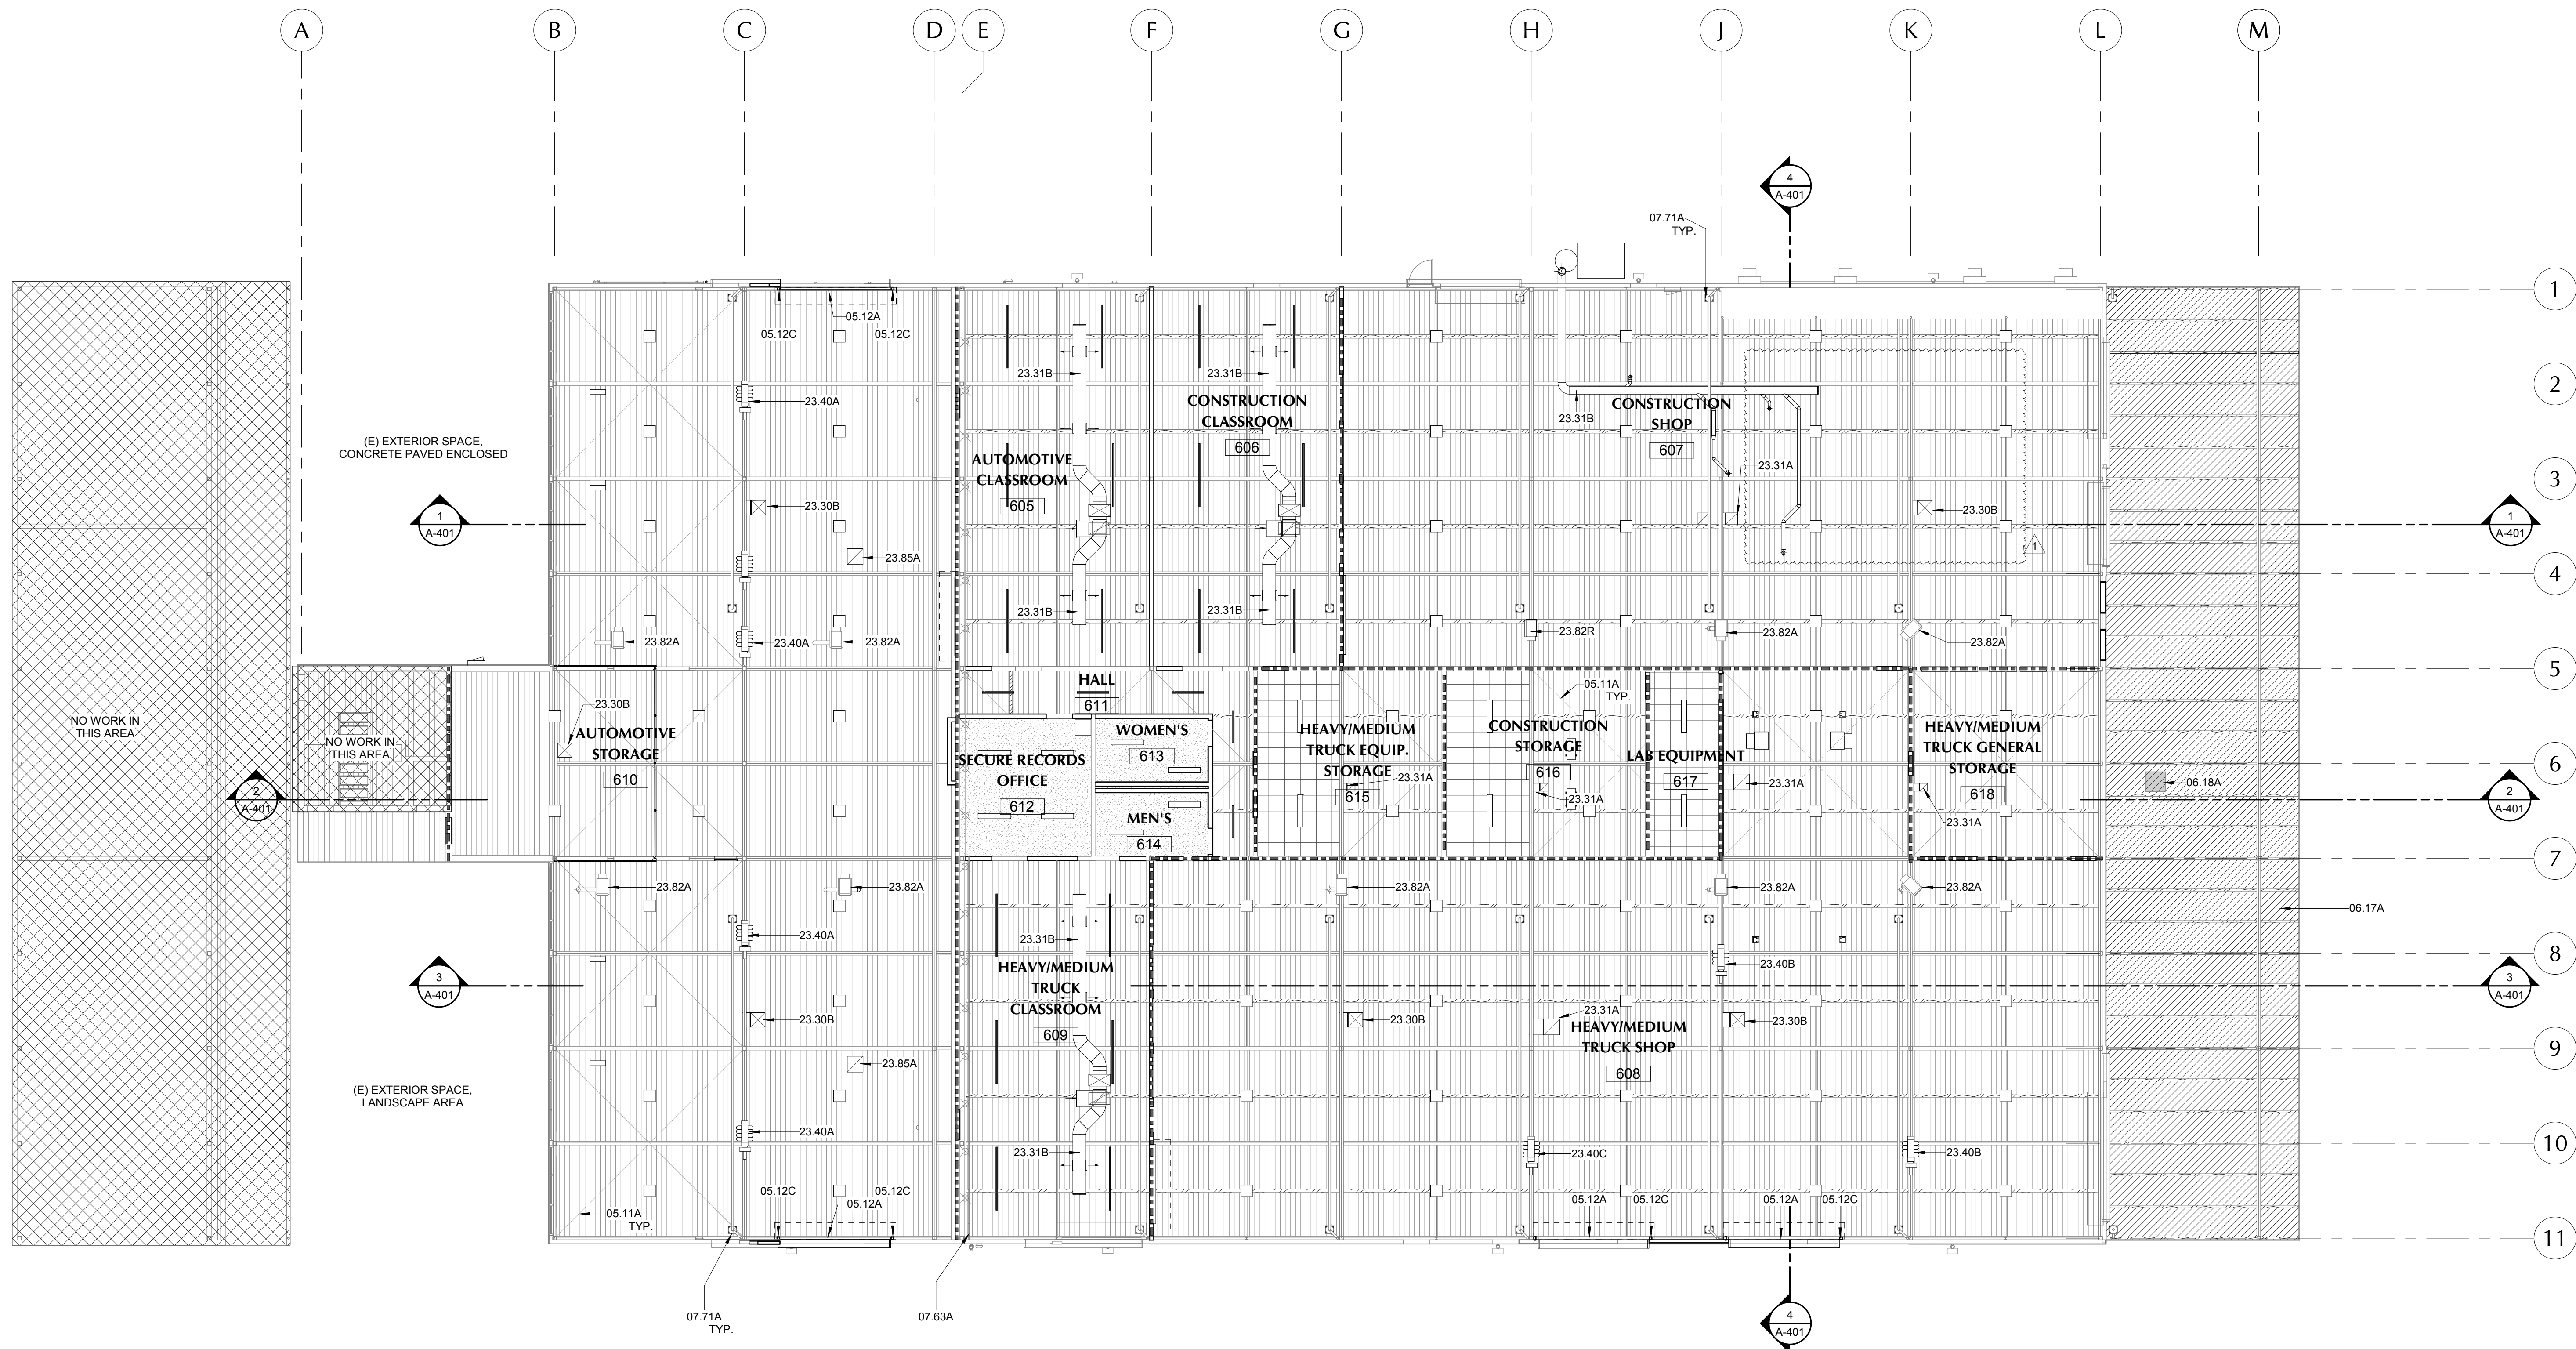

- ANY EXPOSED DUCTS, PIPES TO BE PAINTED
- ANY EXPOSED STEEL TO BE GALVANIZED AND PAINTED
- NO SURFACE MOUNTED BACK BOXES, PIPES OR CONDUIT
- FOR FRAMED GYP. BD. CEILINGS, SEE DETAILS 17 & 18/S-111

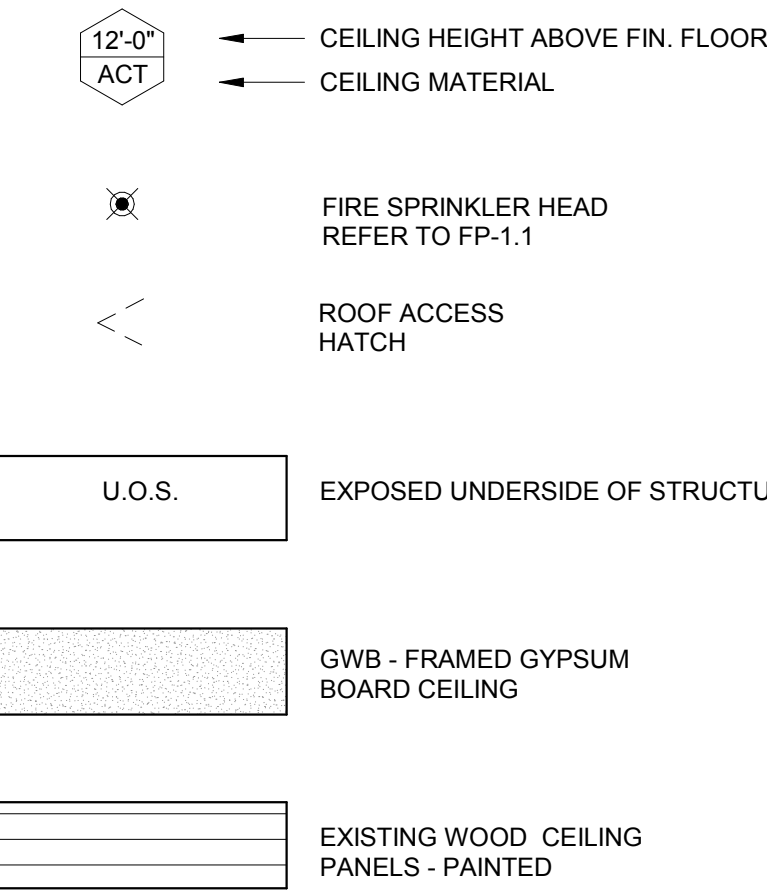

- 8' LED PENDANT LIGHT FIXTURE
- 4' LED PENDENT LIGHT FIXTURE
- SEMI RECESSED LIGHT FIXTURE
- AIR SUPPLY DIFFUSER, SEE ALSO MECHANICAL PLANS
- SUPPLY AND RETURN DIFFUSER PER MECHANICAL DRAWINGS

- SUPPLY REGISTER PER MECHANICAL DRAWINGS
- EXHAUST FAN OR GRILLE PER MECHANICAL DRAWINGS
- 2' x 2' SUSPENDED LIGHT FIXTURE
- RETURN AIR GRILLE PER MECHANICAL DRAWINGS
- EXIT SIGN - SEE ALSO ELECTRICAL LIGHTING PLANS

NOTE: SYMBOLS SHOWN FOR LOCATION PURPOSES ONLY. SEE MECHANICAL, ELECTRICAL, & FIRE PROTECTION DRAWINGS FOR DETAILED INFORMATION

- 05.11A (E) CROSS-BRACING STEEL RODS TO REMAIN. PROTECT IN PLACE.
- 05.12A (N) STRUCTURAL STEEL BEAM PER STRUCTURAL DRAWINGS
- 05.12C (N) STRUCTURAL STEEL COLUMN PER STRUCTURAL DRAWINGS
- 06.17A (E) DIAGONAL ROOF SHEATHING
- 06.18A (N) INFILL REPAIR OF OPENING IN (E) DIAGONAL SHEATHING AT REMOVED EQUIPMENT
- 07.63A (E) FIRE SPRINKLER LINE AT 2 HOUR FIRE RATED WALL, PROTECT IN PLACE.
- 07.71A (E) ROOF DRAIN AND OVERFLOW TO REMAIN. PROTECT IN PLACE.
- 23.30B (N) DUCT DROP FROM SHOP EVAP COOLER ON ADJACENT ROOF PER MECHANICAL DRAWINGS
- 23.31A (N) MECHANICAL DUCT PER MECHANICAL DRAWINGS
- 23.31B (N) EXPOSED MECHANICAL DUCT PER MECHANICAL DRAWINGS
- 23.40A (N) VEHICLE EXHAUST EXTRACTOR-208 LBS, 460/3, 1/2 HP
- 23.40B (N) VEHICLE EXHAUST EXTRACTOR-243 LBS, 460/3, 3/4 HP
- 23.40C (N) VEHICLE EXHAUST EXTRACTOR-249 LBS, 460/3, 1 HP
- 23.82A (E) UNIT HEATER TO REMAIN
- 23.82R RELOCATED (E) UNIT HEATER AND NEW FLUE PER MECHANICAL DRAWINGS
- 23.85A (N) 24"x24" EXHAUST DROP PER MECHANICAL DRAWINGS

CEILING PLAN 3/32" = 1'-0" 1

GENERAL NOTES

CEILING LEGEND

KEYNOTES



560 HIGUERA STREET
SUITE C
SAN LUIS OBISPO, CA 93401
TEL (805) 476-0399

CONSULTANTS

CIVIL ENGINEER
BLAIR, CHURCH & FLYNN
451 Clovis Avenue, Suite 200
Clovis, CA 93612
TEL (559) 326-1400

COST ESTIMATOR
LELAND SAYLOR ASSOCIATES
101 Montgomery Street, Suite 800
San Francisco, CA 94104
TEL (415) 291-3200

STRUCTURAL ENGINEER
BIGGS CARDOSA ASSOCIATES INC.
5250 N. Palm Avenue, Suite 211
Fresno, CA 93704
TEL (805) 499-8686


MECHANICAL ENGINEER
MECHANICAL DESIGN CONCEPTS, INC.
1060 W. Sierra, Suite 101
Fresno, CA 93711
TEL (559) 437-0376

ELECTRICAL ENGINEER
THOMAS ENGINEERING
3562 Emplon Street, Suite C
San Luis Obispo, CA 93401
TEL (805) 543-3850

FIRE PROTECTION ENGINEER
COLLINGS & ASSOCIATES, LLC
260 Maple Court, Suite 241
Ventura, CA 93003
TEL (805) 658-0003

ARCHITECT STAMP

CONSULTANT STAMP

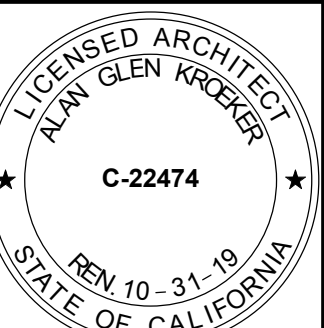

AGENCY APPROVAL
IDENTIFICATION STAMP
DIV. OF THE STATE ARCHITECT

FILE NO. 20-H3
APPL 02-116098
AC FL SS
DATE

REVISIONS

#	DATE	DESCRIPTION
1	03/28/2019	BID ADDENDUM NO. 2

THE ARCHITECT DOES NOT REPRESENT THAT THESE PLANS OR THE SPECIFICATIONS ARE SUITABLE FOR ANY SITE OTHER THAN THE ONE FOR WHICH THEY WERE SPECIFICALLY PREPARED. THE ARCHITECT DISCLAIMS RESPONSIBILITY FOR THESE PLANS AND SPECIFICATIONS IF THEY ARE USED IN WHOLE OR IN PART AT ANY OTHER SITE

PROJECT OWNER & TITLE
Madera Unified School District
1902 Howard Road
Madera, CA 93637

MADERA CTE
MODERNIZATION
200 SOUTH L STREET
MADERA, CA 93637

SHEET TITLE
BUILDING
REFLECTED
CEILING PLAN

DRAWN BY: SR JOB NUMBER: 16052.01
SHEET NO.


A-211

DATE: JUNE 29, 2018

C:\Users\slking\Documents\16052 Madera CTE Modernization_2017_Current_sking.rvt

EQUIPMENT SCHEDULE																					
ROOM NUMBER	ID	COUNT	MODEL NO.	MANUFACTURER	EQUIPMENT DESCRIPTION	RESPONSIBILITY	ELECTRICAL					DIMENSIONS				WASTE		WATER			
							Volts	Kw	Amp	HP	Phase	Conn	Length	Width	Height	Weight	Size	Conn	Cold	Hot	Stub Ht.
E-2			DC-1	AUTOLAND SCIENTECH	DIAGNOSTIC CART	OFOI															
E-3			2605T7	MCMMASTER CARR	HAND TRUCK	OFOI															
608	E-4		RS-500	RANGER PRODUCTS	SPRAY WASH CABINET	OFOI															
E-5			JKP-17	JET	DRILL PRESS	OFOI	110/220			2	1										
604/608	E-6		4115113	MCMMASTER CARR	55 GALLON STEEL DRUM	OFOI															
608	E-7		5017T58	MCMMASTER CARR	EXTRA HEAVY DUTY PALLET RACKS	OFOI															
608	E-8			GLOBAL INDUSTRIAL	TELESCOPIC CRANE	OFOI															
E-9			TCX625PHD	HUNTER	HEAVY DUTY TIRE CHANGER	OFOI		1.5													
E-10			MTS-924	MARTINS INDUSTRIES	HEAVY DUTY TIRE RACK	OFOI															
E-11					TOOL CABINETS	OFOI															
610/616	E-12	6		MCMMASTER CARR	EXTRA HEAVY DUTY PALLET RACKS	OFOI															
609	E-15		5720	SUNNEX	20 TON SHOP PRESS	OFOI															
608	E-16		8609	SUNNEX	10 TON SERVICE JACK	OFOI															
608	E-17		42000C	OMEGA AUTOMOTIVE	1 TON TRANSMISSION JACK	OFOI															
608	E-18			MCMMASTER CARR	STAINLESS STEEL TABLE W. SHELF	OFOI															
608	E-19		8059T34	MCMMASTER CARR	6 TON JACK STAND	OFOI															
608/607	E-20		6AC60M	STANLY VIDMAR	FLAMMABLE SAFETY CABINET	OFOI															
608/607	E-21		6AC60M	STANLY VIDMAR	COMBUSTIBLE SAFETY CABINET	OFOI															
604/608	E-23		14293	EASTWOOD	20 GALLON PARTS WASHER	OFOI	110/120		10												
605/606/609	E-24		C201	AVERCHARGE	20 DEVICE CHARGING CART	OFOI	100-120X200-240														
616	E-25			MCMMASTER CARR	HEAVY DUTY SHELVING	OFOI															
608	E-26		MTS-924	MARTIN INDUSTRIES	TIRE RACK	OFOI															
608	E-27		42735	ROUGINECK	15 GALLON DRAIN DOLLY	OFOI															
608	E-28		71320	GRANGER	TRUCK WHEEL DOLLY	OFOI															
607	E-30	8			WORK BENCH W/ BENCH DOG	OFOI															
608	E-31		34988NI	ROBINAIR	A/C REFRIGERANT MACHINE	OFOI	240V														
608	E-32			VALUE BRAND	PORTABLE TOOL RACK	OFOI															
608	E-33				AXLE MOUNT	OFOI															
608	E-34				STEERING UNIT	OFOI															
607	E-35				(E) PANEL SAW	OFOI															
608	E-36		7173K26	MCMMASTER	INDOOR CHARGER/STARTER	OFOI	120X220														
608	E-37		WT684	HUNTER	HEAVY TRUCK ALIGNMENT RACK AND CONSOLE	OFOI	120														
607	E-38				SAW DUST COLLECTOR	OFOI															
608	E-39		HW93776	HEIN-WERNER	3 TON ENGINE STAND	OFOI															
608	E-40			HUNTER	HEAVY DUTY SHELVING	OFOI															
E-41				MCMMASTER CARR	EXTRA HEAVY DUTY SHELVING	OFOI															
E-42	12			LINCOLN	(E) ELECTRIC WELDERS ON WHEELED CARTS	OFOI															
607	E-43	12			(E) OXYACETYLENE WELDING UNITS	OFOI															
N/A	E-44	1	2103DS12VCB23	QUINCY	AIR COMPRESSOR	OFOI	230V/3 PHASE														
E-45			QRHT100	QUINCY	REFRIGERATED AIR DRYER	OFOI	115V/1/60	1.7													
604/607/608	E-46	11	5635 OLP (A)	REELCRAFT	OVERHEAD HOSE REEL (AIR)	OFOI															
604/608	E-47		5635 OLP (W)	REELCRAFT	OVERHEAD HOSE REEL (WATER)	OFOI															
604/607/608	E-48		L 70100 123 3A	REELCRAFT	POWER AND LIGHT CORD REELS	OFOI															
608	E-49	1	TR-25	MOHAWK	FOUR POST VEHICLE LIFT	OFOI															
E-50	2		SYSTEM 1	MOHAWK	VEHICLE LIFT AND STAGE ARMS	OFOI															
E-51	2		LC-12	MOHAWK	VEHICLE LIFT AND STAGE ARMS	OFOI															
604/610	E-52				TOOL CHIST	OFOI															
604	E-53	1			SHOP WORK BENCH	OFOI															
607	E-54	2	SS-IC553230CBF36	SAW STOP	TABLE SAW	OFOI	220														
E-55	4		MP-18	MOHAWK	MOBILE LIFT	OFOI															
E-56	4			SHAIN	BUTCHER TOP WORK TABLE	OFOI															
E-57				TOYOTA		OFOI															

FORK LIFT

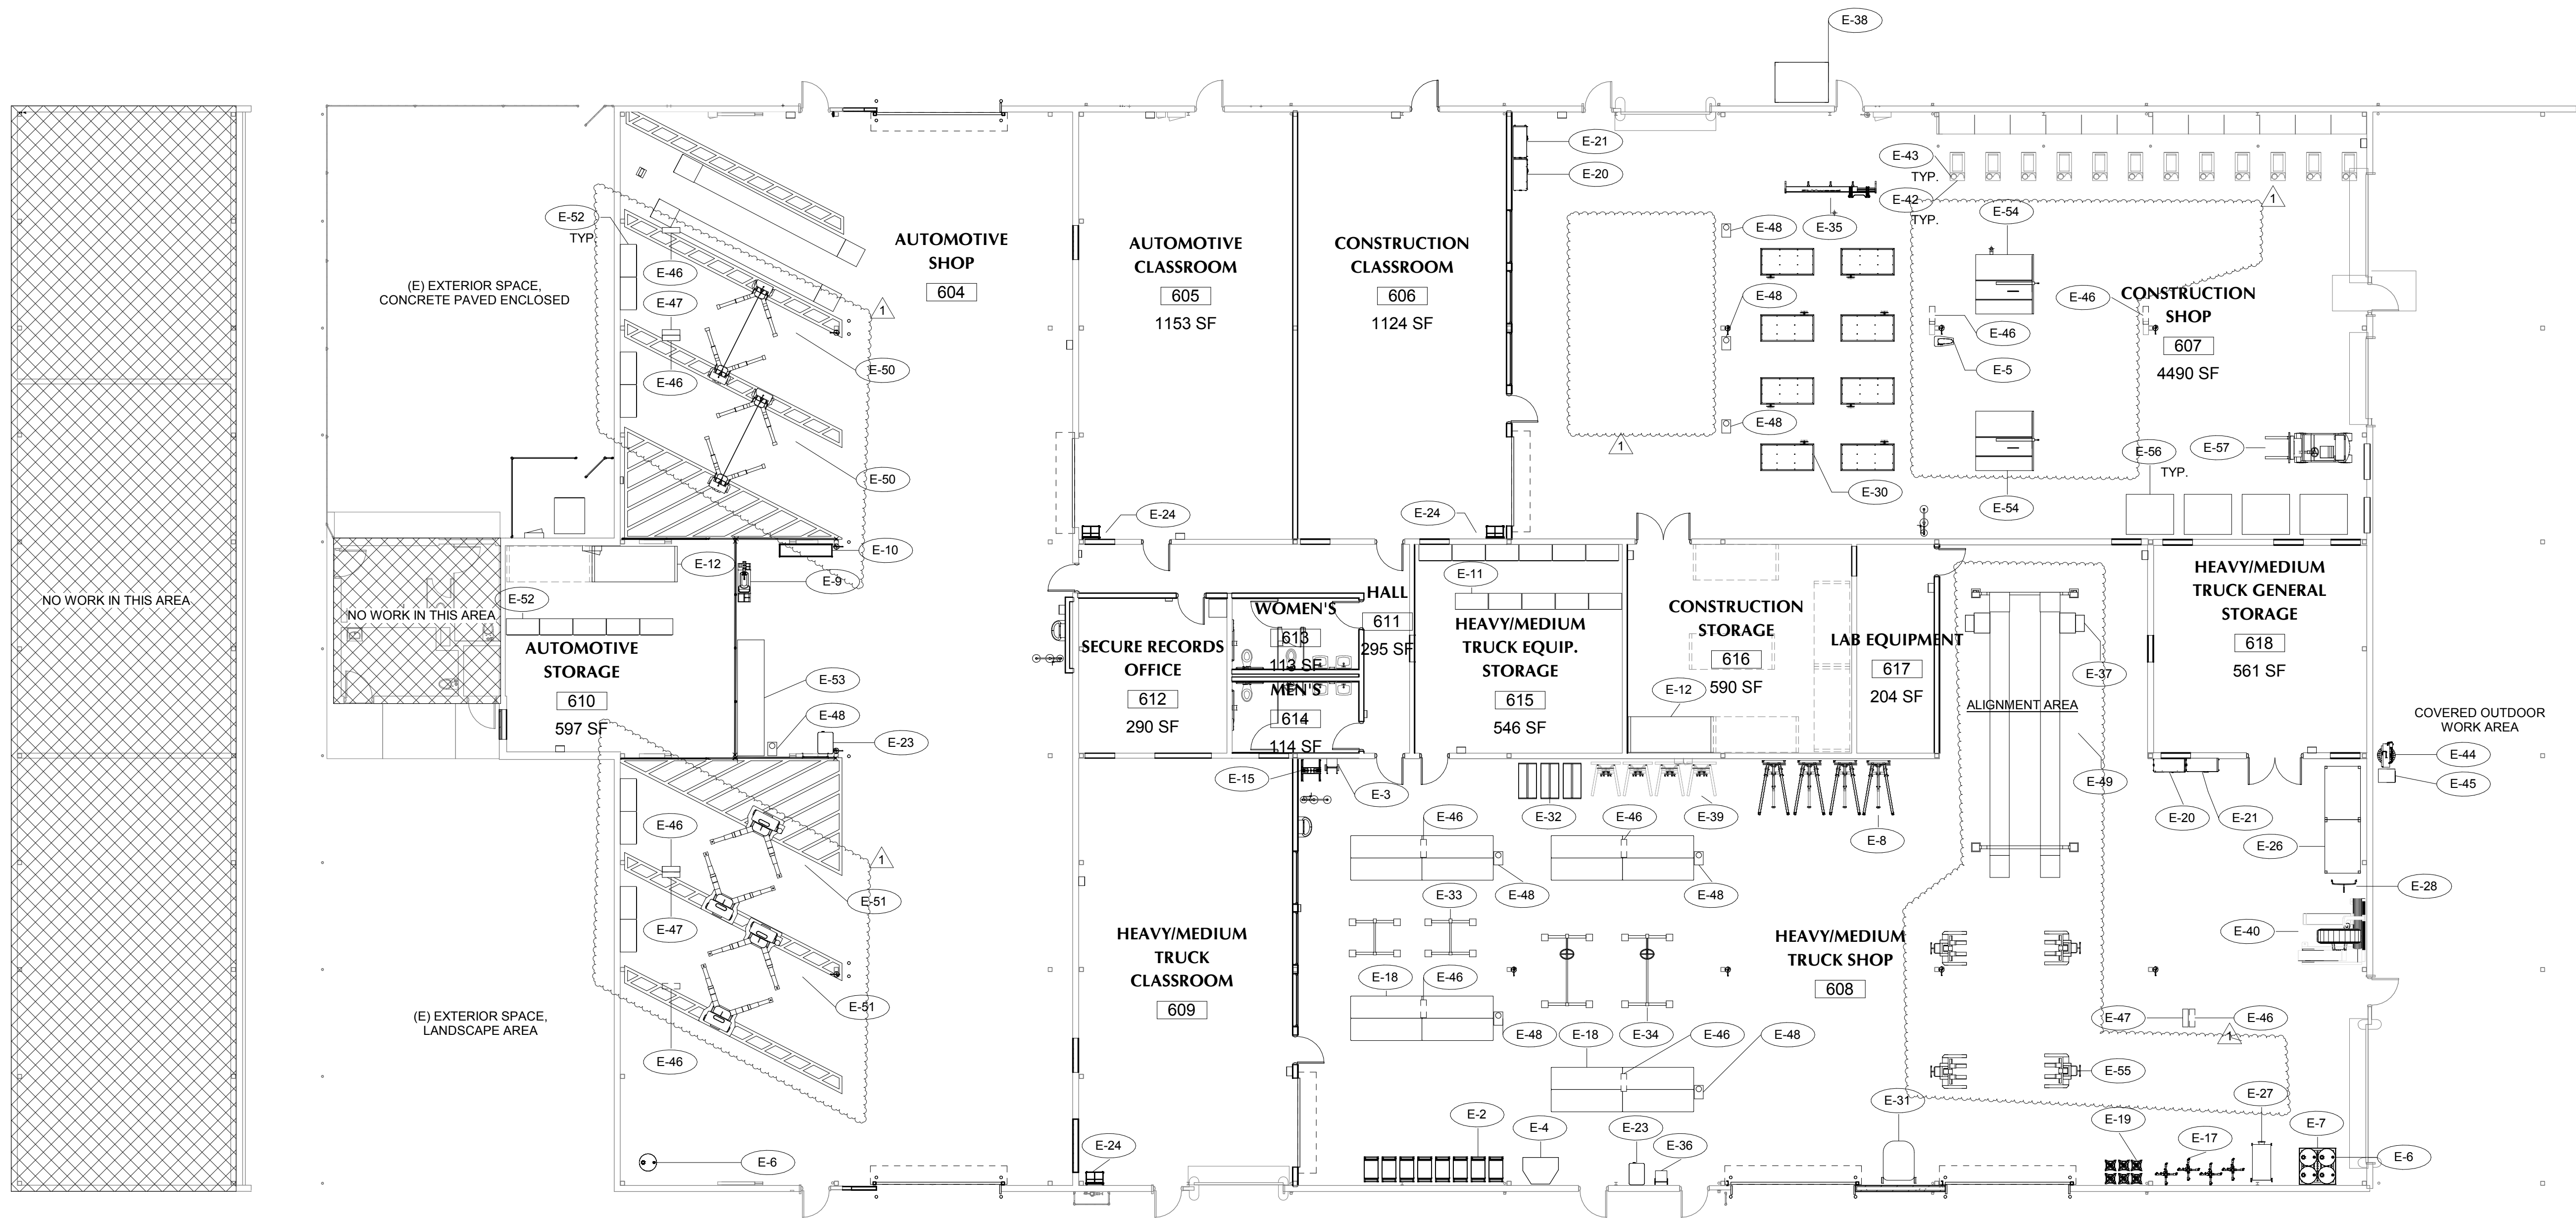

PMSM

ARCHITECTS

560 HIGUERA STREET
SUITE C
SAN LUIS OBISPO, CA 93401
TEL (805) 476-0399

CONSULTANTS

CIVIL ENGINEER
BLAIR, CHURCH & FLYNN
451 Clovis Avenue, Suite 200
Clovis, CA 93612
TEL (559) 326-1400

COST ESTIMATOR
LELAND SAYLOR ASSOCIATES
101 Montgomery Street, Suite 800
San Francisco, CA 94104
TEL (415) 291-3200

STRUCTURAL ENGINEER
BIGGS CARDOSA ASSOCIATES INC.
5250 N. Palm Avenue, Suite 211
Fresno, CA 93704
TEL (805) 499-8686

MECHANICAL ENGINEER
MECHANICAL DESIGN CONCEPTS, INC.
1060 W. Sierra, Suite 101
Fresno, CA 93711
TEL (559) 437-0376

ELECTRICAL ENGINEER
THOMAS ENGINEERING
3562 Emory Street, Suite C
San Luis Obispo, CA 93401
TEL (805) 543-3850

FIRE PROTECTION ENGINEER
COLLINGS & ASSOCIATES, LLC
260 Maple Court, Suite 241
Ventura, CA 93003
TEL (805) 658-0003

ARCHITECT STAMP

CONSULTANT STAMP



AGENCY APPROVAL
IDENTIFICATION STAMP
DIV. OF THE STATE ARCHITECT

FILE NO. 20-H3
APPL. 02-116098
AC ____ FL ____ SS ____
DATE ____

REVISIONS

#	DATE	DESCRIPTION
1	03/28/2019	BID ADDENDUM NO. 2

THE ARCHITECT DOES NOT REPRESENT THAT THESE PLANS OR THE SPECIFICATIONS ARE SUITABLE FOR ANY SITE OTHER THAN THE ONE FOR WHICH THEY WERE SPECIFICALLY PREPARED. THE ARCHITECT DISCLAIMS RESPONSIBILITY FOR THESE PLANS AND SPECIFICATIONS IF THEY ARE USED IN WHOLE OR IN PART AT ANY OTHER SITE

PROJECT OWNER & TITLE
Madera Unified School District
1902 Howard Road
Madera, CA 93637

MADERA CTE
MODERNIZATION
200 SOUTH L STREET
MADERA, CA 93637

SHEET TITLE
EQUIPMENT PLAN
AND SCHEDULE

DRAWN BY: SR
SHEET NO.
JOB NUMBER: 16052.01

A-231

DATE: JUNE 29, 2018

EQUIPMENT FLOOR PLAN

3/32" = 1'-0"

1

DSA BACK CHECK 3/29/2019 9:44:06 AM